


ELECTRICAL LEGEND

 
- ALUMINUM STEP LUMINAIRE
- ACCESSORY POT LUMINAIRE
- SURFACE MOUNTED LUMINAIRE
- WALL MOUNTED LUMINAIRE
- CEILING OR STEEL MOUNTED HALOGEN FURNACE
- TRACE LIGHT
- POLE MOUNTED LUMINAIRE
- SLONG DIMMER SWITCH
- SMOKE POLE SWITCH
- THREE WAY SWITCH
- THIRTY WAY SWITCH
- THIRTY WAY SWITCH
- DUPLEX RECEPTACLE
- SWITCH & DUPLEX RECEPTACLE
- SWITCH OUTLET
- WASHER OUTLET
- PROOF OUTLET
- RANGE OUTLET
- VOLTAIR FAN
- CASEMATION FAN
- FLUSH FLOOR MOUNTED DUPLEX RECEPTACLE
- WELDER PROOF RECEPTACLE
- 120/250V PANELBOARD
- TELEPHONE OUTLET
- CEILING MOUNTED SMOKE DETECTOR
- WALL MOUNTED SMOKE DETECTOR
- SECURITY ALARM
- WALL MOUNTED MOTION DETECTOR
- AUTOMATIC GARAGE OPENER
- ROOM WALL SWITCH
- ROOM WALL
- FURNACE

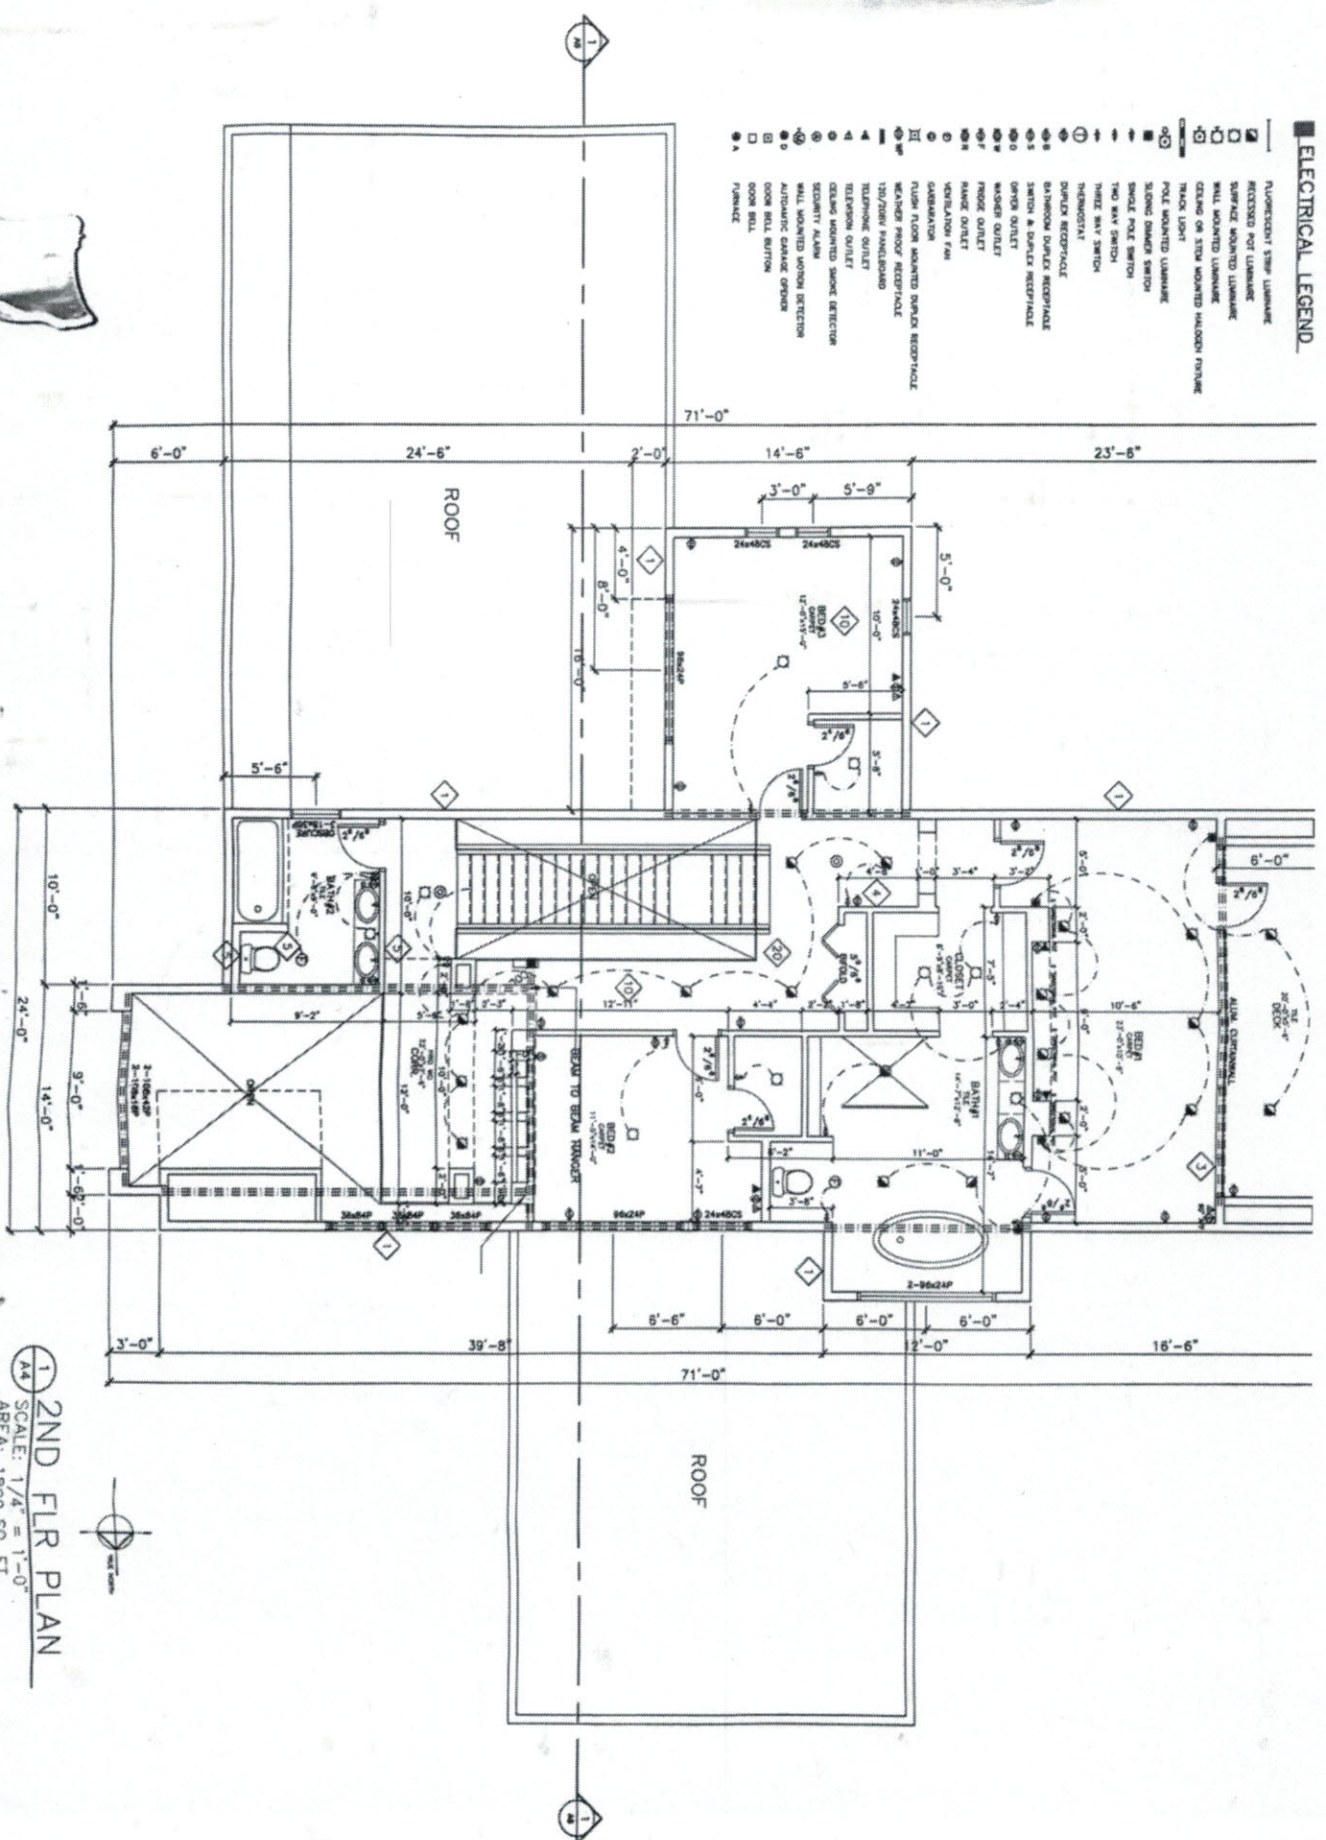


1 2ND FLR PLAN
 SCALE: 1/4" = 1'-0"
 AREA: 1890 SQ. FT.

DAO RESIDENCE

 FLUORESCENT STRIP LIGHTING
 *WICH RECEIVED POT LIGHTING
 SURFACE MOUNTED LIGHTING
 WALL MOUNTED LIGHTING
 CEILING OR STEP MOUNTED HALOGEN FIXTURE
 TRACK LIGHT



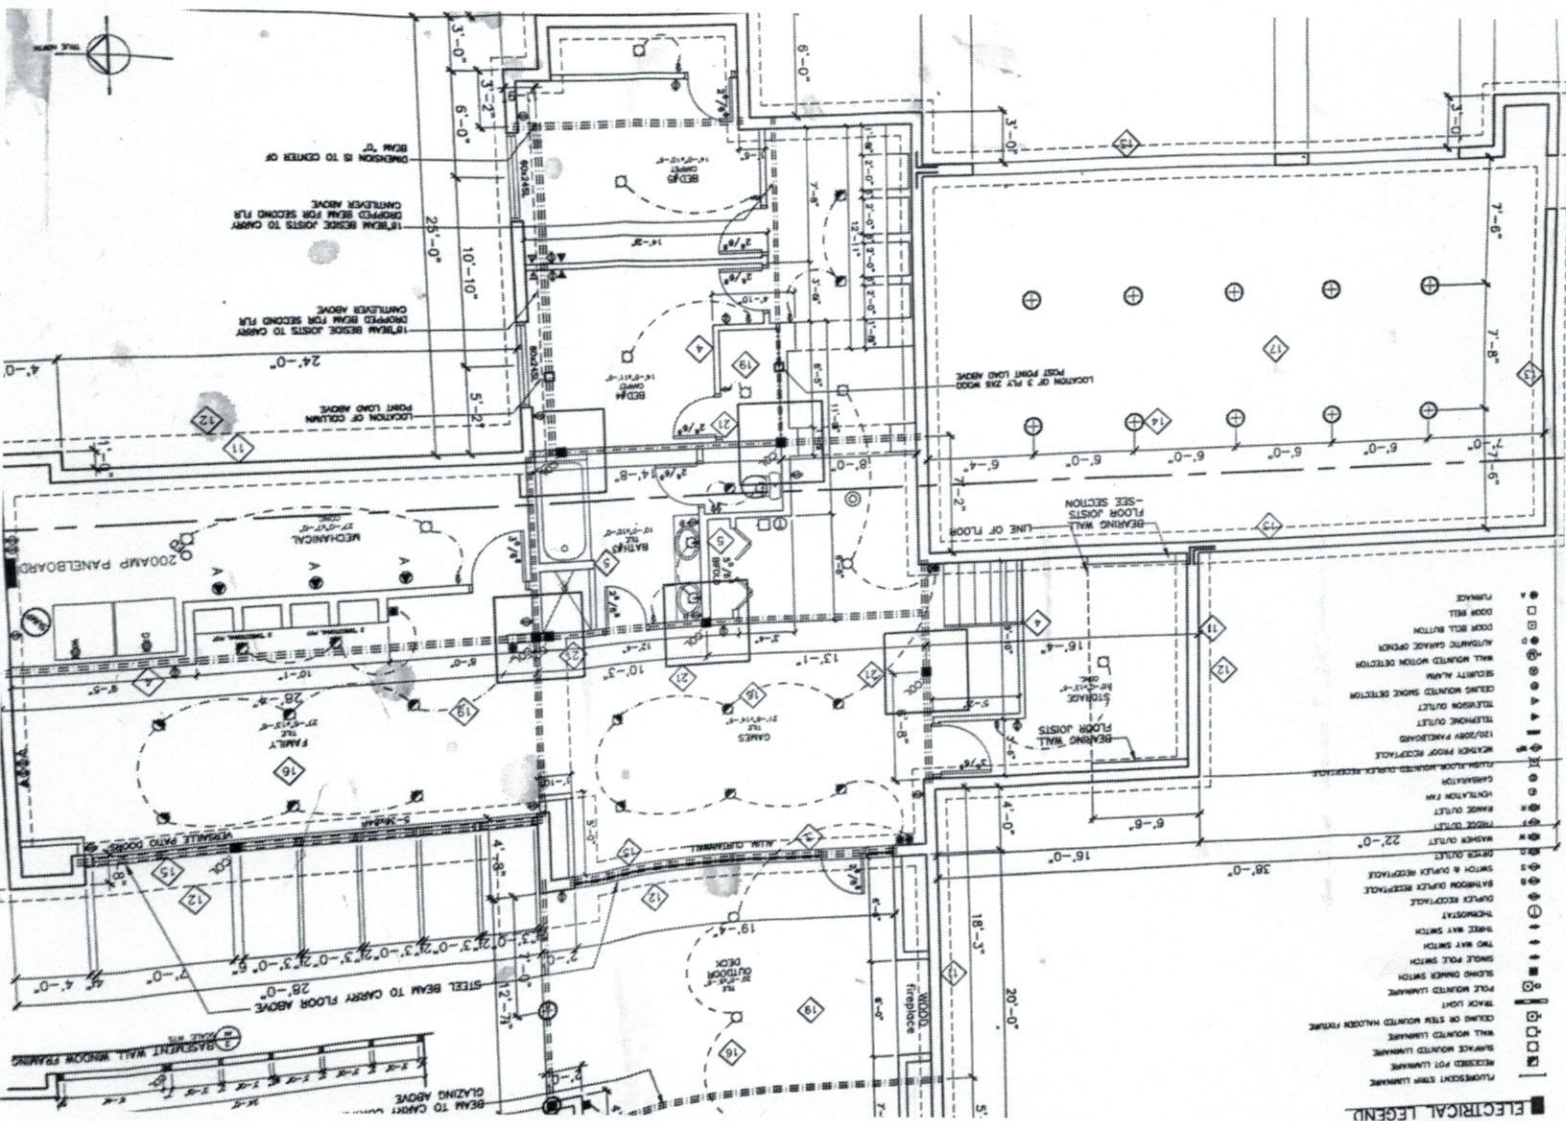

ELECTRICAL LEGEND